


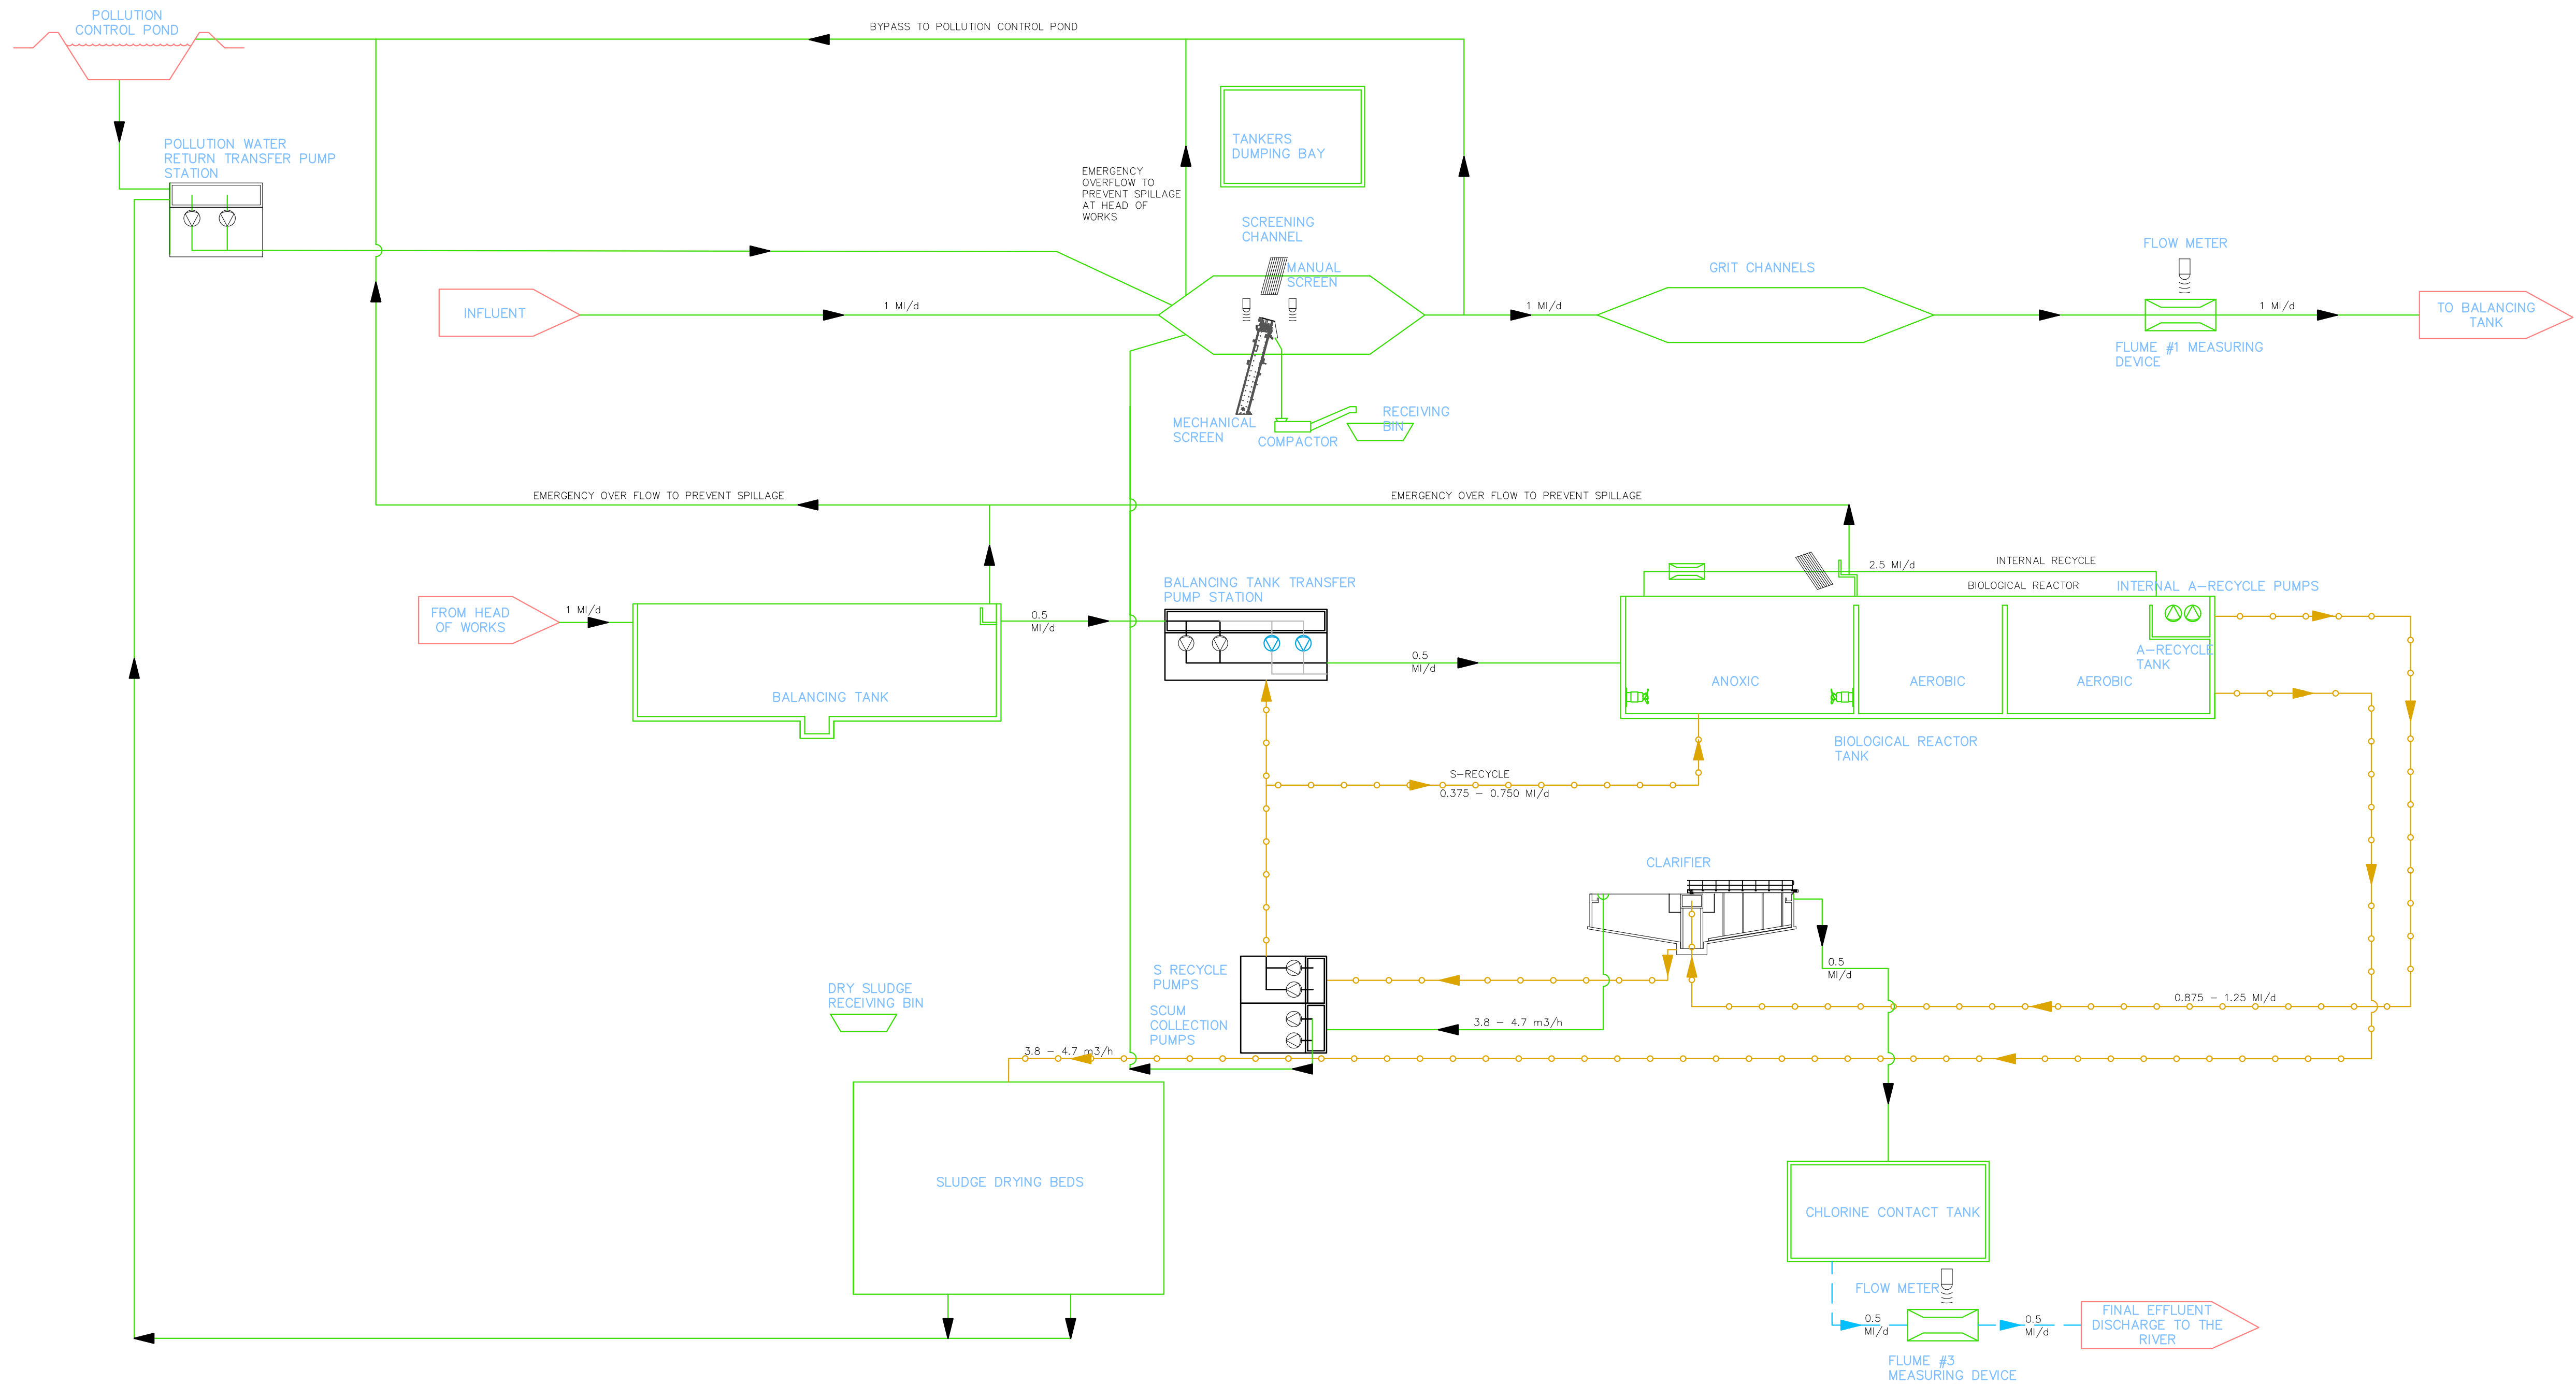

NEW WOODLANDS WWTW PROCESS FLOW DIAGRAM
SCALE 1:1000

FOR INFORMATION

AMENDMENTS			
REV	DATE	DESCRIPTION	INITIALS
0	MAY 2025	FOR INFORMATION	DF

DRAWING NOTES

SERVICE AUTHORITY APPROVAL

POSITION	NAME	DATE	SIGNATURE

CLIENT(S)

SIGNATURE _____ DATE _____

PROJECT TITLE

UPGRADE OF BULK SEWERS,
REPLACING OF SMALL-BORE
SANITATION SYSTEM AT
WOODLANDS

DRAWING TITLE

NEW WOODLANDS WWTW
PROCESS FLOW DIAGRAM

SCALE: AS SHOWN
PAPER SIZE: A0

COORD SYSTEM
WGS84 - L028



SIGNATURE _____

PR _____

DATE _____

PROCESS	NAME	DATE
DESIGNED	D. FUNYUFUNYU	2025/05/14
CHECKED	M. KRUGER	2025/05/14
VERIFIED		
DRAWN	D. FUNYUFUNYU	2025/05/14
CHECKED	M. KRUGER	2025/05/14
SMEC DRAWING NO.: EC0047-GEN-GA-0001		REV 0
SHT 1 OF 1		